


SEE SHEET A2.1 FOR LOADING DECK PLAN & DETAILS

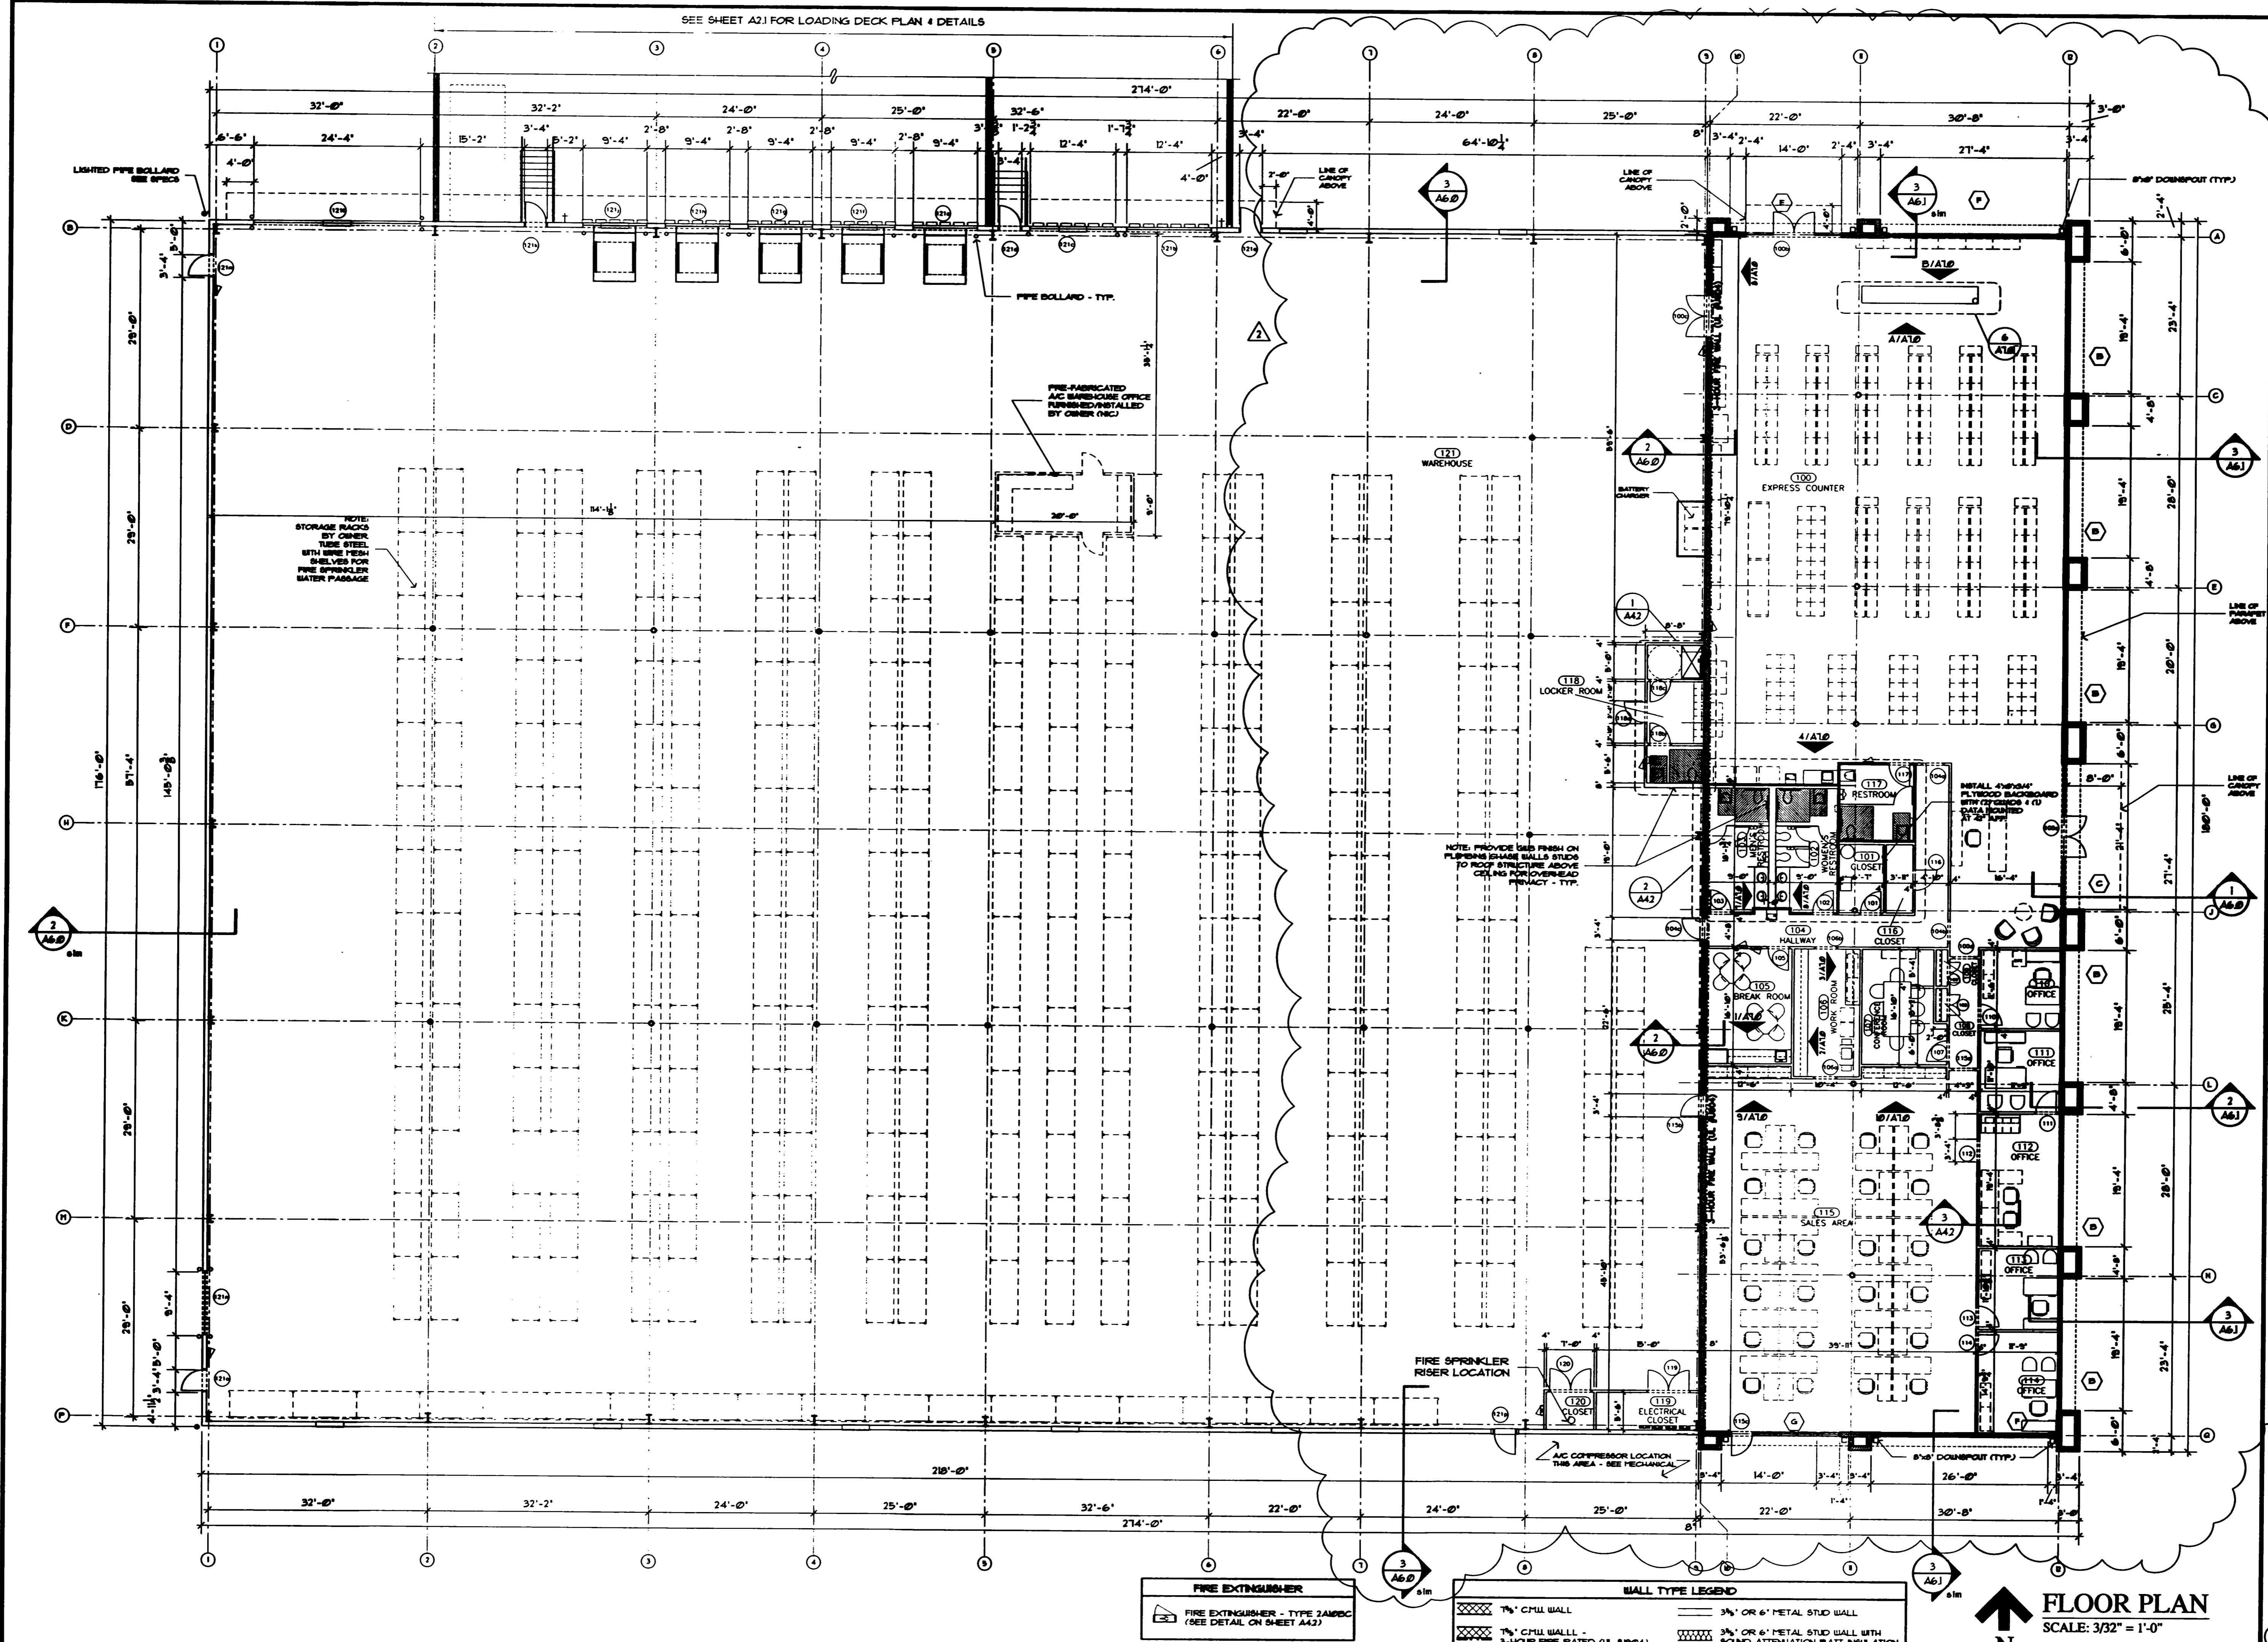

NOTE: STORAGE RACKS BY OWNER. TUBE STEEL WITH WIRE MESH SHELVES FOR FIRE SPRINKLER WATER PASSAGE.

PRE-FABRICATED A/C WAREHOUSE OFFICE FURNISHED/INSTALLED BY OWNER (N/C)

NOTE: PROVIDE GRAB BARS ON PLUMBING CHASE WALLS STUCCO TO ROOF STRUCTURE ABOVE CEILING FOR OVERHEAD TRAFFIC - TYP.


FIRE EXTINGUISHER
FIRE EXTINGUISHER - TYPE 2A/BC (SEE DETAIL ON SHEET A4.2)

WALL TYPE LEGEND
1/2" CMU WALL
3/4" CMU WALL - 3-HOUR FIRE RATED (UL 4564)
3/4" OR 6" METAL STUD WALL
3/4" OR 6" METAL STUD WALL WITH SOUND ATTENUATION BATT INSULATION

FLOOR PLAN
SCALE: 3/32" = 1'-0"

REVISIONS	
2	OWNER REV. 5/25/2024

JERALD C. OWEN • ARCHITECT
 OFFICE: 1680 MARAVILLA AVENUE
 FORT MYERS, FLORIDA 33901
 OFFICE: (239) 482-7402 FAX: (239) 482-7402
 ELECTRONIC MAIL: JCO3361@USA.com
 FL. AR # 13,244 AIA # 30157205 NCARB # 41,506

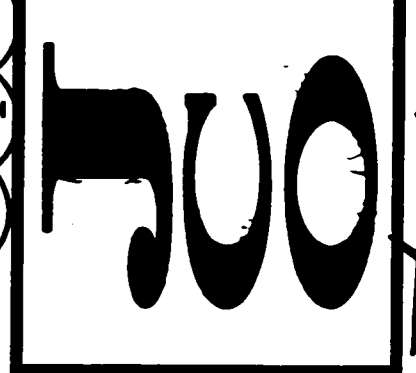

Construction Documents for:
Office / Warehouse Building
 for **FERGUSON ENTERPRISES INC.**
 Ford Street - Fort Myers, Florida 33901

JOB: 0308
 DATE: 01-12-04
 CAD REF: 0308-A2.0
 DRAWN BY: JCO

SHEET
A2.0

© 2003 Jerald C. Owen Architect Inc. This drawing is copyrighted and cannot be reproduced in part or in whole without the written consent from the Architect.